



MATCHLINE FOR CONTINUATION SEE DWG C-219

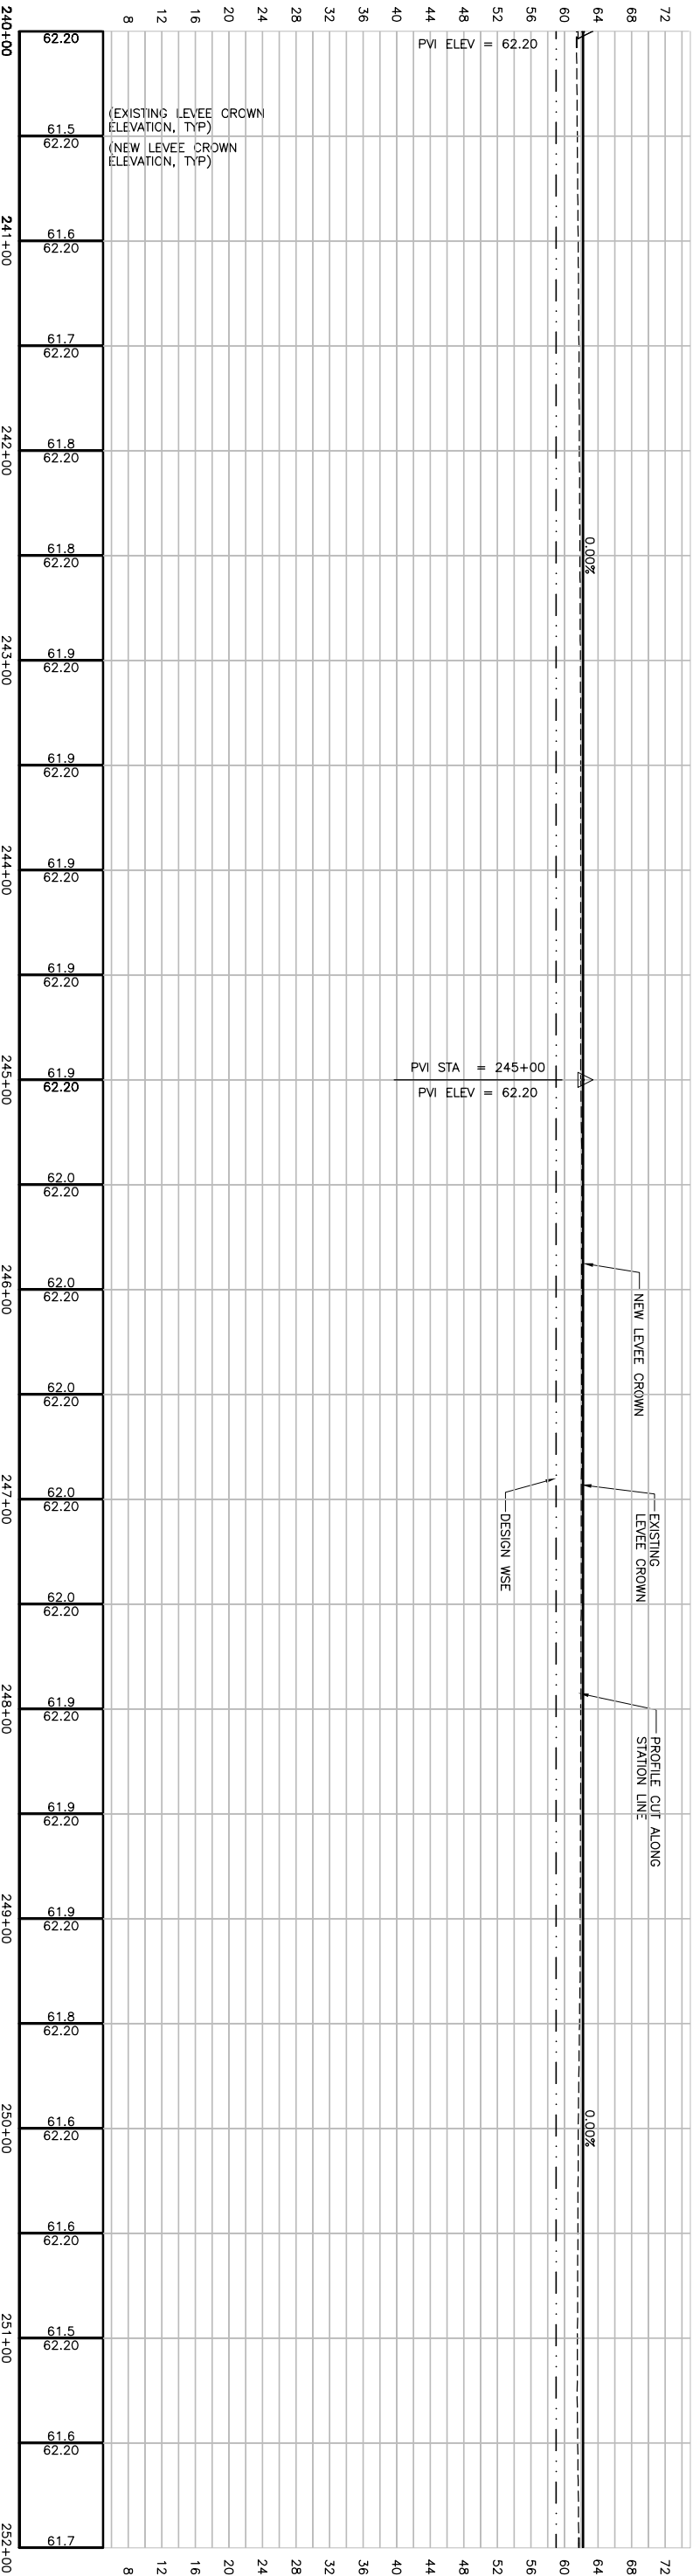


**PROFILE**  
SCALE: HORIZ: 1" = 40'  
VERT: 1" = 10'

**PLAN**  
SCALE: 1" = 40'

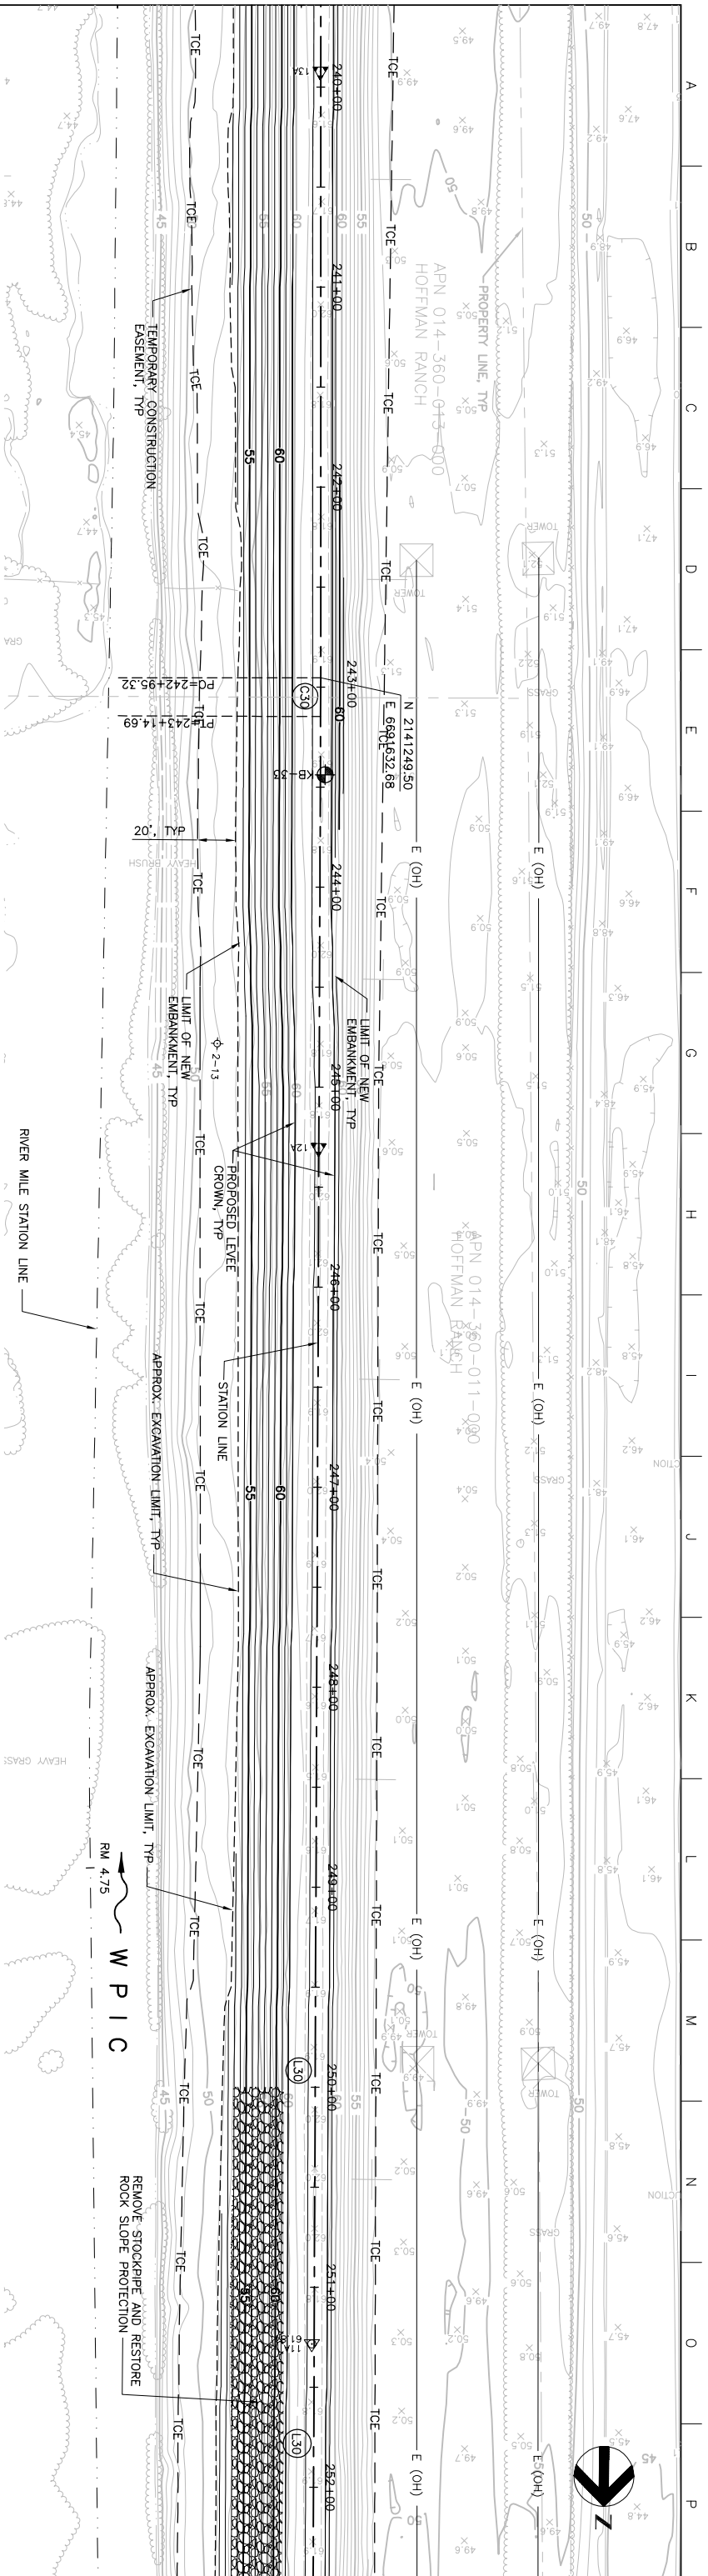

MATCHLINE FOR CONTINUATION SEE DWG C-221

Issue No.	Description	Date	Drawn	Checked	Revised By	Project No.
0	ISSUED FOR CONSTRUCTION	5/18/05	ACC	PHH	CEK	KRM

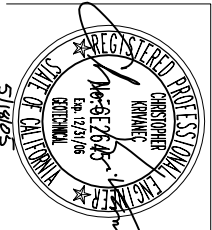

**HDR**  
HDR Engineering, Inc.

Project Manager	K. MYERS
Designed	C. KRIVANEC
Checked	P. HRADLICK
Drawn	A. COLLINS

Phase II Levee Repairs  
Upper Bear River, W/P Interceptor Canal and Yuba River  
Reclamation District No. 784  
Marysville, California  
Three Rivers Levee Improvement Authority

**WPIC**  
**PLAN AND PROFILE**

Date	MAY, 2005	Project No.	201064-19703	Drawing No.	C-220
Scale	AS NOTED	File Name	C220.DWG	Issue	X